




NASSAU COUNTY

BRANDY BRANCH  
POWER PLAN  
METER STATION

PROPOSED 24" PIPELINE

CLAY COUNTY

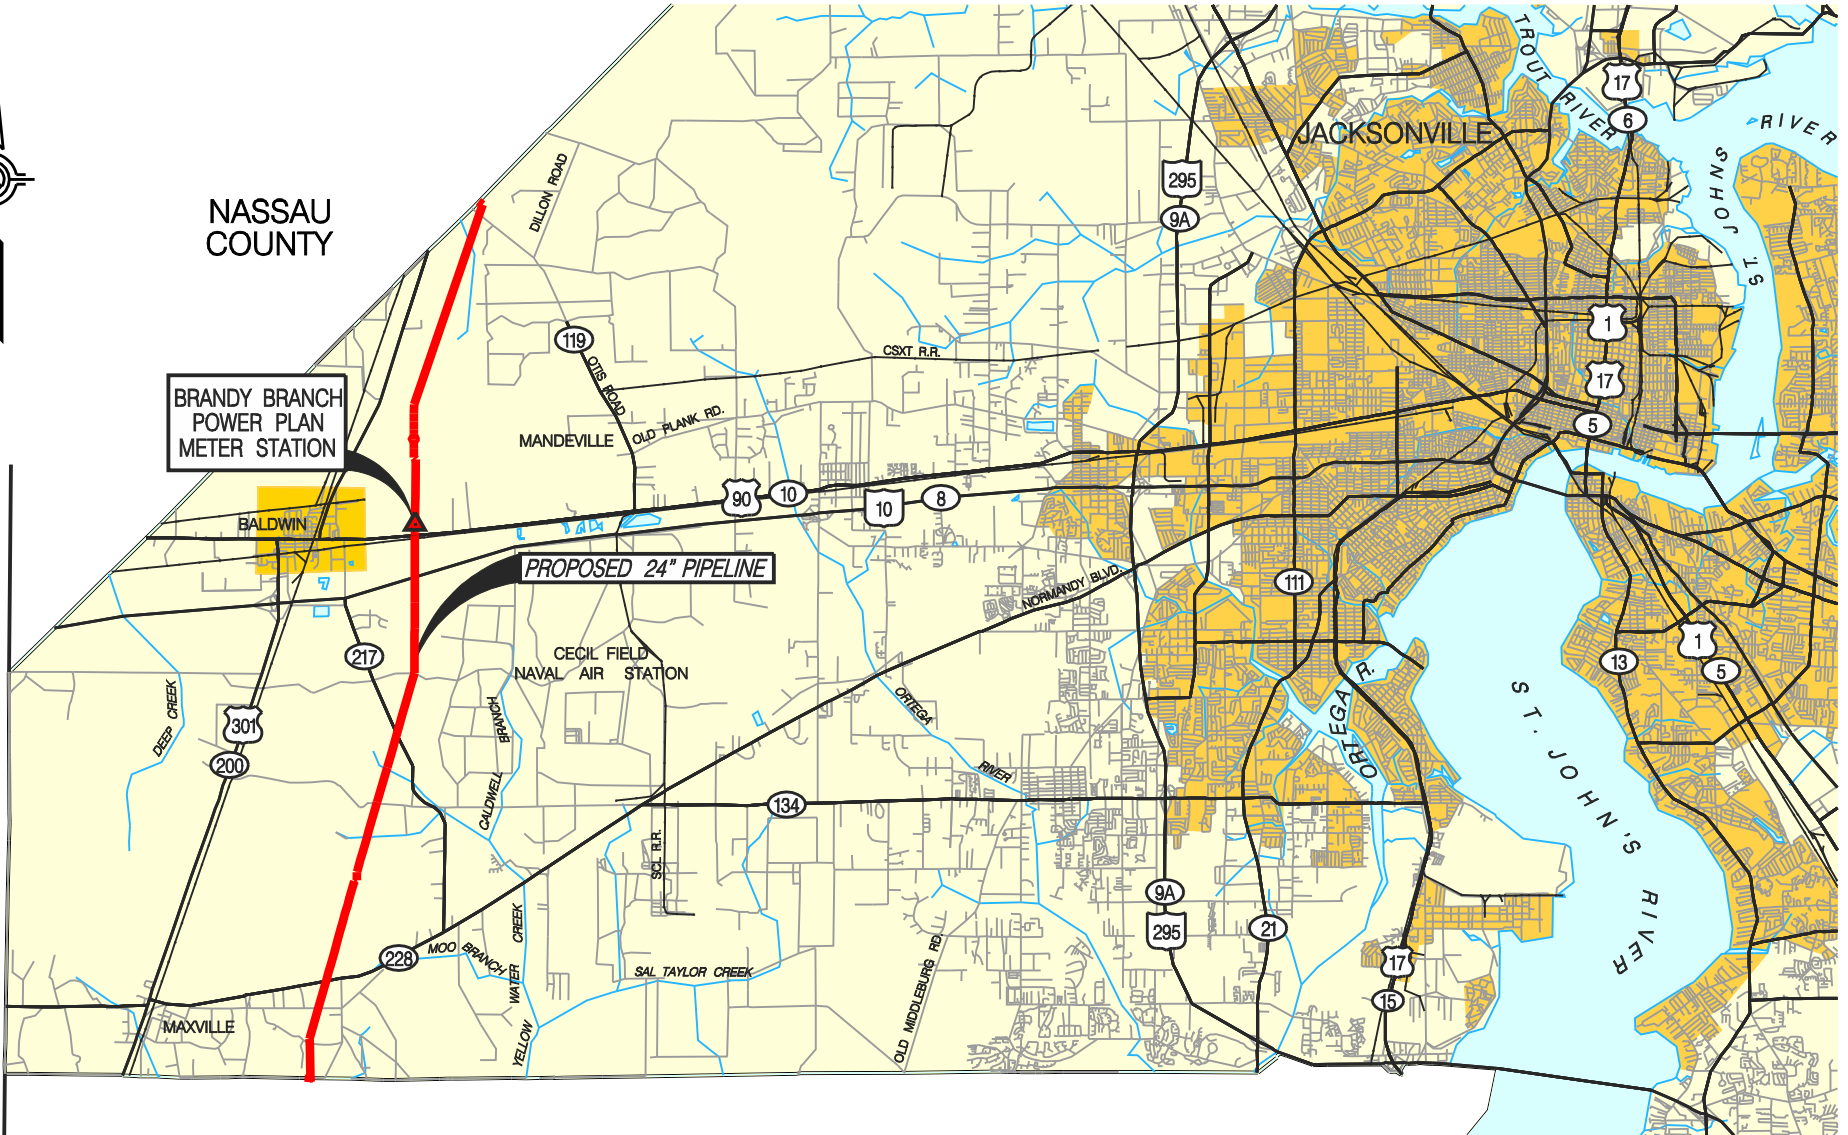

SOUTHERN NATURAL GAS  
An El Paso Company

|             |     |      |          |
|-------------|-----|------|----------|
| DWN. BY:    | GIE | DATE | 12/17/04 |
| CHK.        |     |      |          |
| PROJ. ENGR. |     |      |          |
| PROJ. MGR.  |     |      |          |
| CLIENT APP. |     |      |          |

**CYPRESS PIPELINE PROJECT**  
**DUVAL COUNTY, FLORIDA**  
**PIPELINE ROUTE MAP**

|        |                |          |      |
|--------|----------------|----------|------|
| SCALE: | DWG. NO.       | SHT. NO. | REV. |
| N.T.S. | 1063-10-A-0122 |          | A    |

| NO. | REVISION-DESCRIPTION    | BY  | DATE     | CHK'D | APP'D |
|-----|-------------------------|-----|----------|-------|-------|
| A   | PROPOSED PIPELINE ROUTE | GIE | 12/17/04 |       |       |